


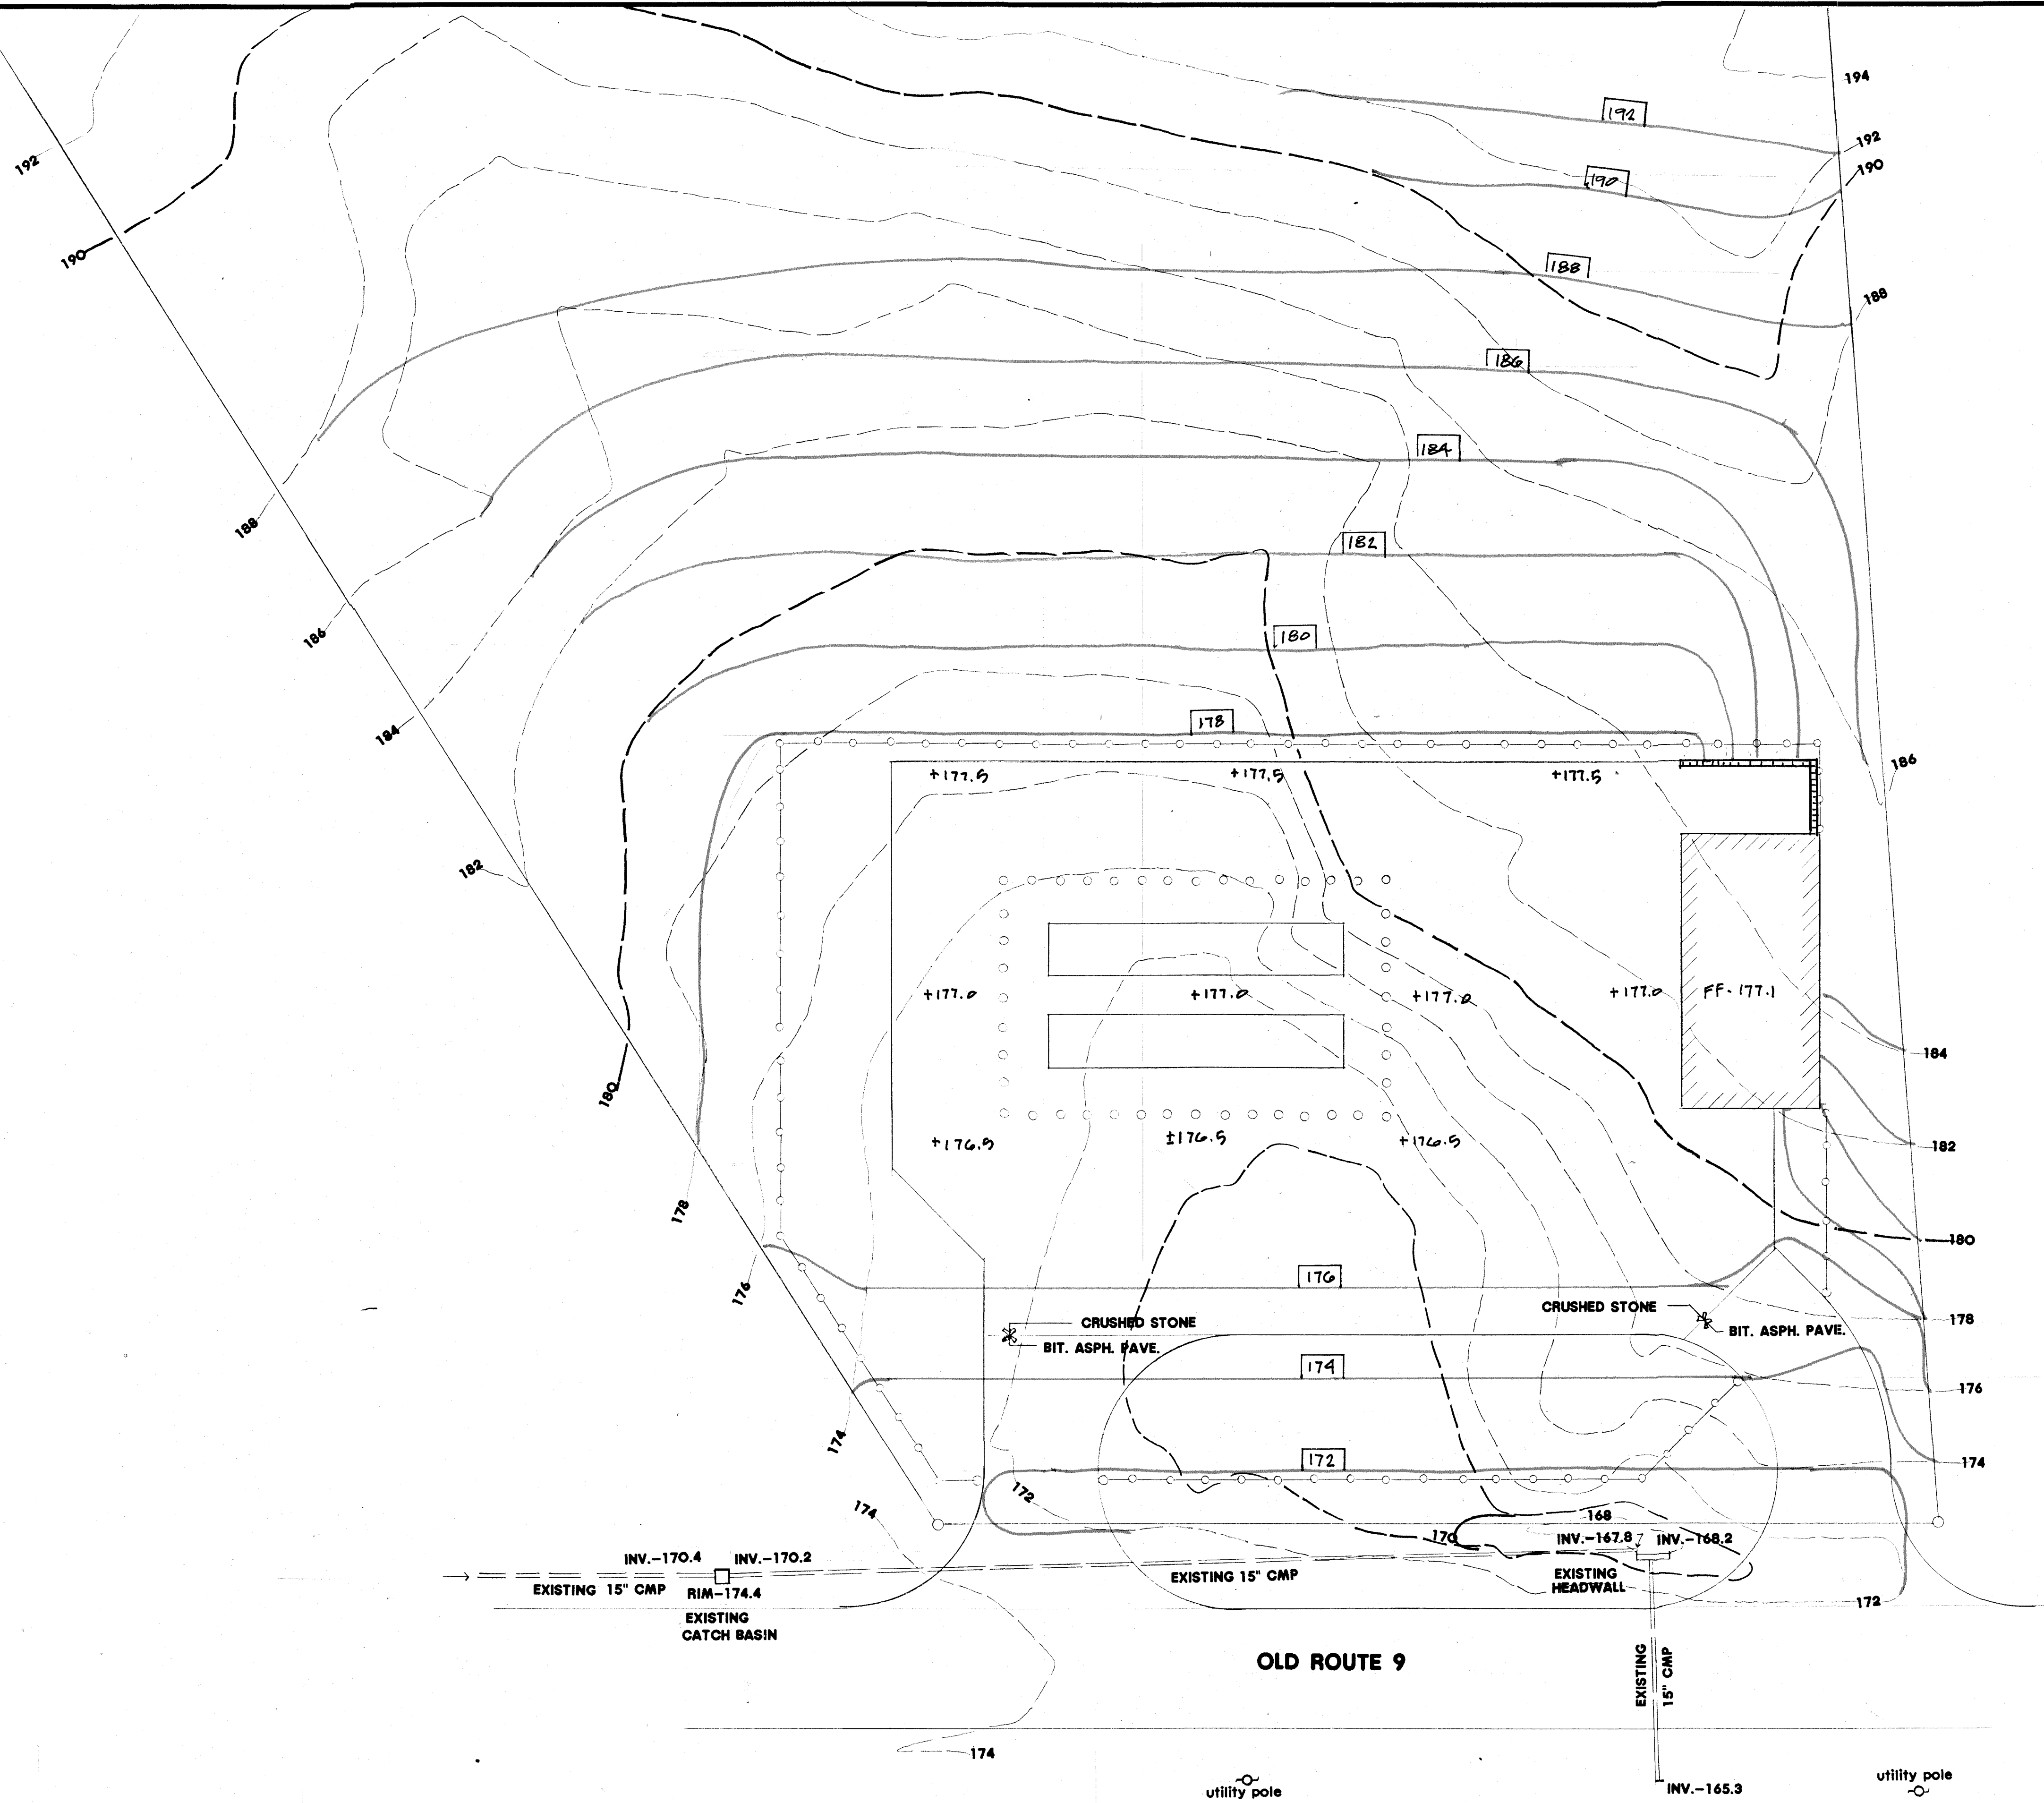

GRADING & DRAINAGE PLAN (CONCEPTUAL)

REVISIONS	BY

ALFRED A. CAPPELLI Jr., AIA
ARCHITECT
 1136 ROUTE 9 WAPPINGERS FALLS, N.Y. 12590
 Phone: (845) 632-6500
 acappel2102@aol.com

PROPOSED LIQUID PROPANE STORAGE FACILITY
DOWNNEY ENERGY
 OLD ROUTE 9
 TOWN OF WAPPINGER, NY

GRADING & DRAINAGE PLAN
(CONCEPTUAL)

DATE	FEB. 20, 2020
SCALE	1" = 20'
DRAWN	AC
JOB	19-013
SHEET	S-4
OF	SHEETS